

BROOKSTONE SENIOR LIVING

DINO DRIVE, BURTONSVILLE, MD
ELDERHOME SENIOR LIVING, LLC
CONDITIONAL USE SUBMISSION

CONSULTANTS

PROJECT TITLE


**BROOKSTONE
SENIOR LIVING**

ISSUE #	DATE	DESCRIPTION
	09/30/2022	CONDITIONAL USE
	05/11/2023	CONDITIONAL USE RE-SUBMISSION

RENDERING



PROJECT LOCATION

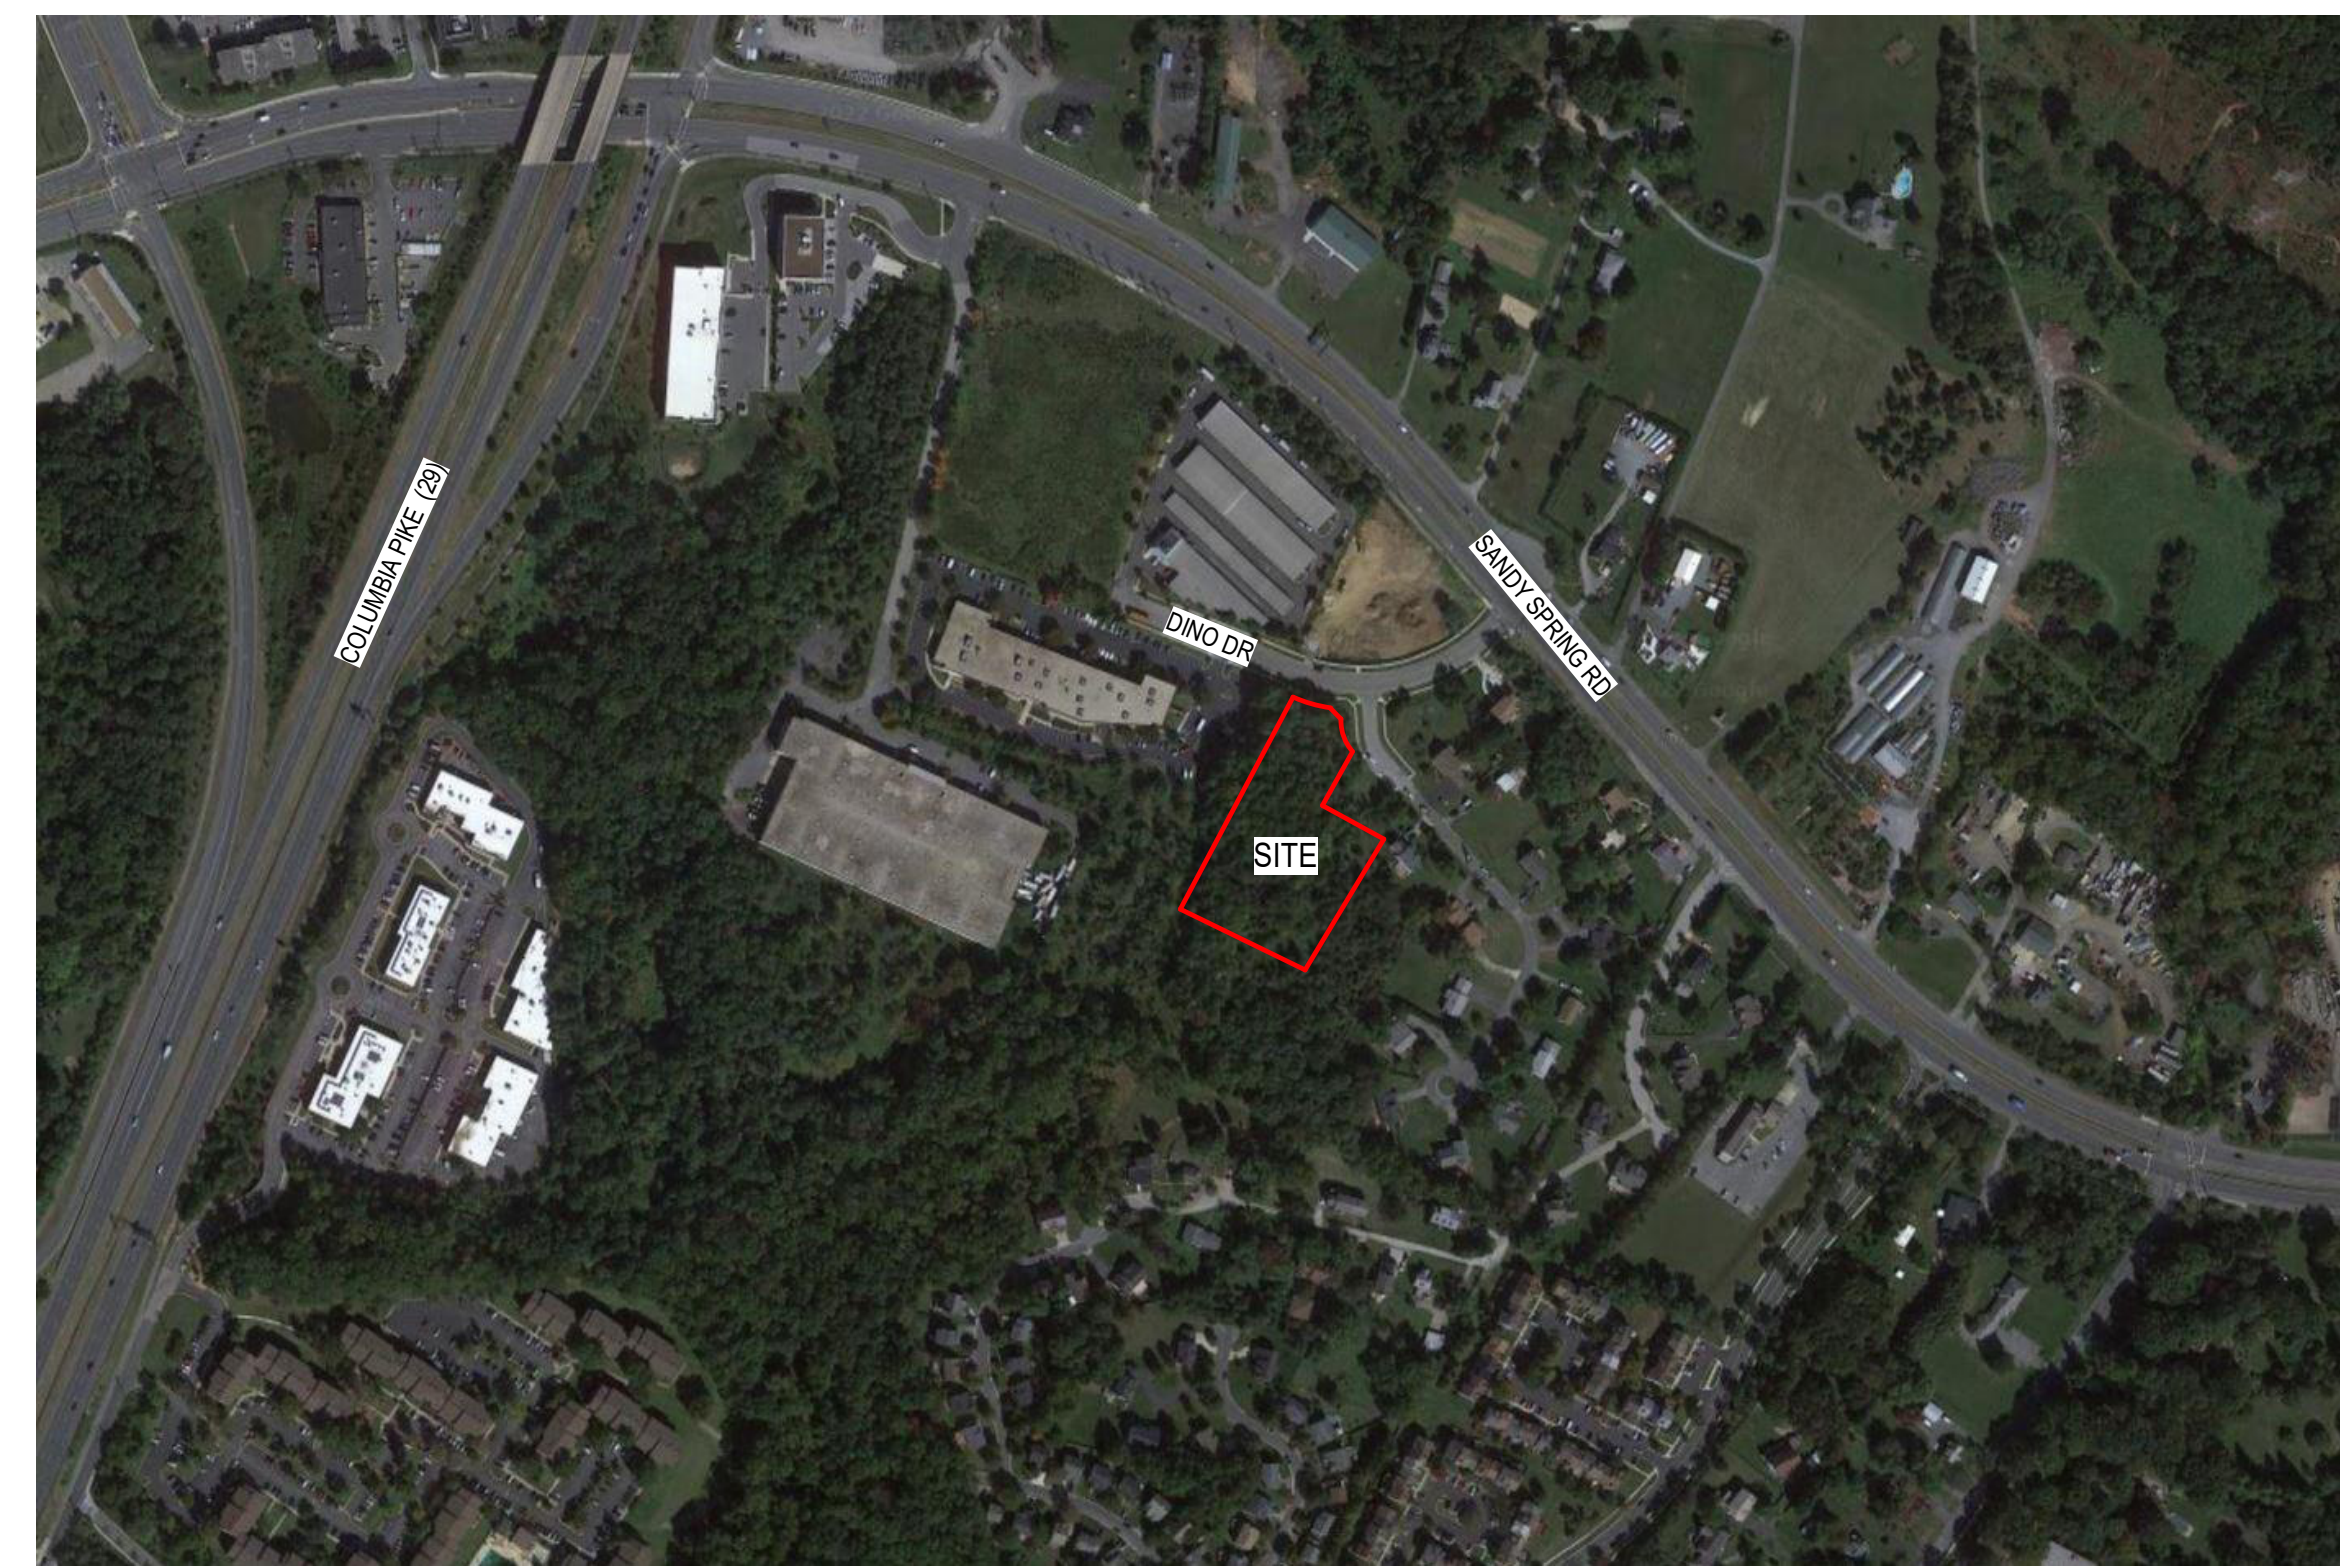

PROJECT TEAM

OWNER / APPLICANT:
ElderHome Senior Living LLC
P.O. Box 310
Ashton, MD 20861
Phone: 240.786.5692
Contact: Tom Norris

Architect:
Boarman Kroos Vogel Group, Inc
1054 31st Street, NW, Suite 410
Washington, DC 20007
Phone: 612.339.3752
Fax: 612.339.6212
Contact: David Banta

Civil:
Packard & Associates, LLC
16220 Frederick Road, Suite 300
Gaithersburg, MD 20877
Phone: 301.208.0250
Contact: Dean Packard

Landscape:
Boarman Kroos Vogel Group, Inc
1054 31st Street, NW, Suite 410
Washington, DC 20007
Phone: 469.556.4239
Contact: Collin Koonce

Structural Engineering:
Boarman Kroos Vogel Group, Inc
1054 31st Street, NW, Suite 410
Washington, DC 20007
Phone: 612.339.3752
Fax: 612.339.6212
Contact: Brian Cornell

Mechanical Engineering:
Boarman Kroos Vogel Group, Inc
1054 31st Street, NW, Suite 410
Washington, DC 20007
Phone: 612.339.3752
Fax: 612.339.6212
Contact: Bill Ljungquist

Electrical Engineering:
Boarman Kroos Vogel Group, Inc
1054 31st Street, NW, Suite 410
Washington, DC 20007
Phone: 612.339.3752
Fax: 612.339.6212
Contact: Chad Kurdi

Interior Design:
Thoma-Holec Design LLC
7255 E Hampton Ave, Ste 112
Mesa, AZ 85209-3312
Phone: 480.671.9307
Contact: Lisa Warnock

CERTIFICATION

NOT FOR
CONSTRUCTION

DRAWN BY	Author
CHECKED BY	Checker
COMMISSION NUMBER	2485-01

SHEET TITLE

COVER SHEET

SHEET NUMBER

G100

SHEET NUMBER	SHEET NAME	D/CD	D/CD 2	SHEET NUMBER	SHEET NAME	D/CD	D/CD 2	SHEET NUMBER	SHEET NAME	D/CD	D/CD 2
GENERAL											
G100	COVER SHEET	X	X	L-001	LANDSCAPE COVER SHEET	X	X	A100	LEVEL 0 FLOOR PLAN	X	X
G120	CODE SUMMARY	X	X	L-002	LANDSCAPE NOTES / GRAPHIC LEGEND	X	X	A101	LEVEL 1 FLOOR PLAN	X	X
CIVIL											
C1	CONDITIONAL USE PLAN COVER SHEET (50 SCALE)	X	X	L-003	OVERALL SITE REFERENCE PLAN	X	X	A102	LEVEL 2 FLOOR PLAN	X	X
C2	EXISTING CONDITIONS PLAN	X	X	L-004	LANDSCAPE MATERIALS SCHEDULE	X	X	A103	LEVEL 3 FLOOR PLAN	X	X
C3	NATURAL RESOURCE INVENTORY/FOREST DELINEATION PLAN	X	X	LP-100	OVERALL PLANTING PLAN	X	X	A104	LEVEL 4 FLOOR PLAN	X	X
C4	NATURAL RESOURCE INVENTORY/FOREST DELINEATION PLAN	X	X	LP-101	PLANTING PLAN	X	X	A140	ROOF PLAN	X	X
C5	CONDITIONAL USE PLAN - SHEET 2 (20 SCALE)	X	X	LP-102	PLANTING PLAN	X	X	A401	EXTERIOR ELEVATIONS	X	X
C6	CONDITIONAL USE PLAN - SHEET 3 (20 SCALE)	X	X	LP-103	PLANTING PLAN	X	X	A501	BUILDING SECTIONS	X	X
C7	CONDITIONAL USE PLAN - SHEET 4 (20 SCALE)	X	X	LP-104	PLANTING PLAN	X	X	D1	MATERIAL BOARD	X	X
C8	LIGHTING PLAN	X	X	LP-201	AMENITY DECK ENLARGEMENT PLANTING PLANS	X	X	D2	PERSPECTIVE VIEW W/ MATERIALS	X	X
C9	FIRE ACCESS PLAN	X	X	LP-202	AMENITY DECK ENLARGEMENT PLANTING PLANS	X	X	D3	PERSPECTIVE VIEW	X	X
C10	STORMWATER MANAGEMENT CONCEPT PLAN - COVER SHEET	X	X	LP-501	PLANTING DETAILS	X	X	D4	PERSPECTIVE VIEW	X	X
C11	STORMWATER MANAGEMENT CONCEPT PLAN - SHEET 2 (20 SCALE)	X	X	LS-100	OVERALL LANDSCAPE PLAN	X	X	D5	PERSPECTIVE VIEW	X	X
C12	STORMWATER MANAGEMENT CONCEPT PLAN - SHEET 3 (20 SCALE)	X	X	LS-101	LANDSCAPE PLAN	X	X	D6	PERSPECTIVE VIEW	X	X
C13	STORMWATER MANAGEMENT CONCEPT PLAN - SHEET 4 (20 SCALE)	X	X	LS-102	LANDSCAPE PLAN	X	X				
C14	PRELIMINARY FOREST CONSERVATION PLAN	X	X	LS-103	LANDSCAPE PLAN	X	X				
C15	PRELIMINARY FOREST CONSERVATION NOTES	X	X	LS-104	LANDSCAPE PLAN	X	X				
C16	UTILITY PLAN - COVER SHEET	X	X	LS-201	AMENITY DECK ENLARGEMENTS	X	X				
C17	UTILITY PLAN - SHEET 2 (20 SCALE)	X	X	LS-202	AMENITY DECK ENLARGEMENTS	X	X				
C18	UTILITY PLAN - SHEET 3 (20 SCALE)	X	X	LS-301	LANDSCAPE DETAILS	X	X				
C19	UTILITY PLAN - SHEET 4 (20 SCALE)	X	X								

Exhibit 39
OZAH Case No: CU 23-12